


PROJECT DATE: Dec. 02, 2009 - 1:10:00am DWG FILE: J:\ACAD1 Drawings\Drawings\03\03137_ Redesign\03137_floor plan for Fire without table ramping.dwg UNCLANDED: This drawing is the property of Jenkins Mumroe Jenkins architecture, all rights reserved

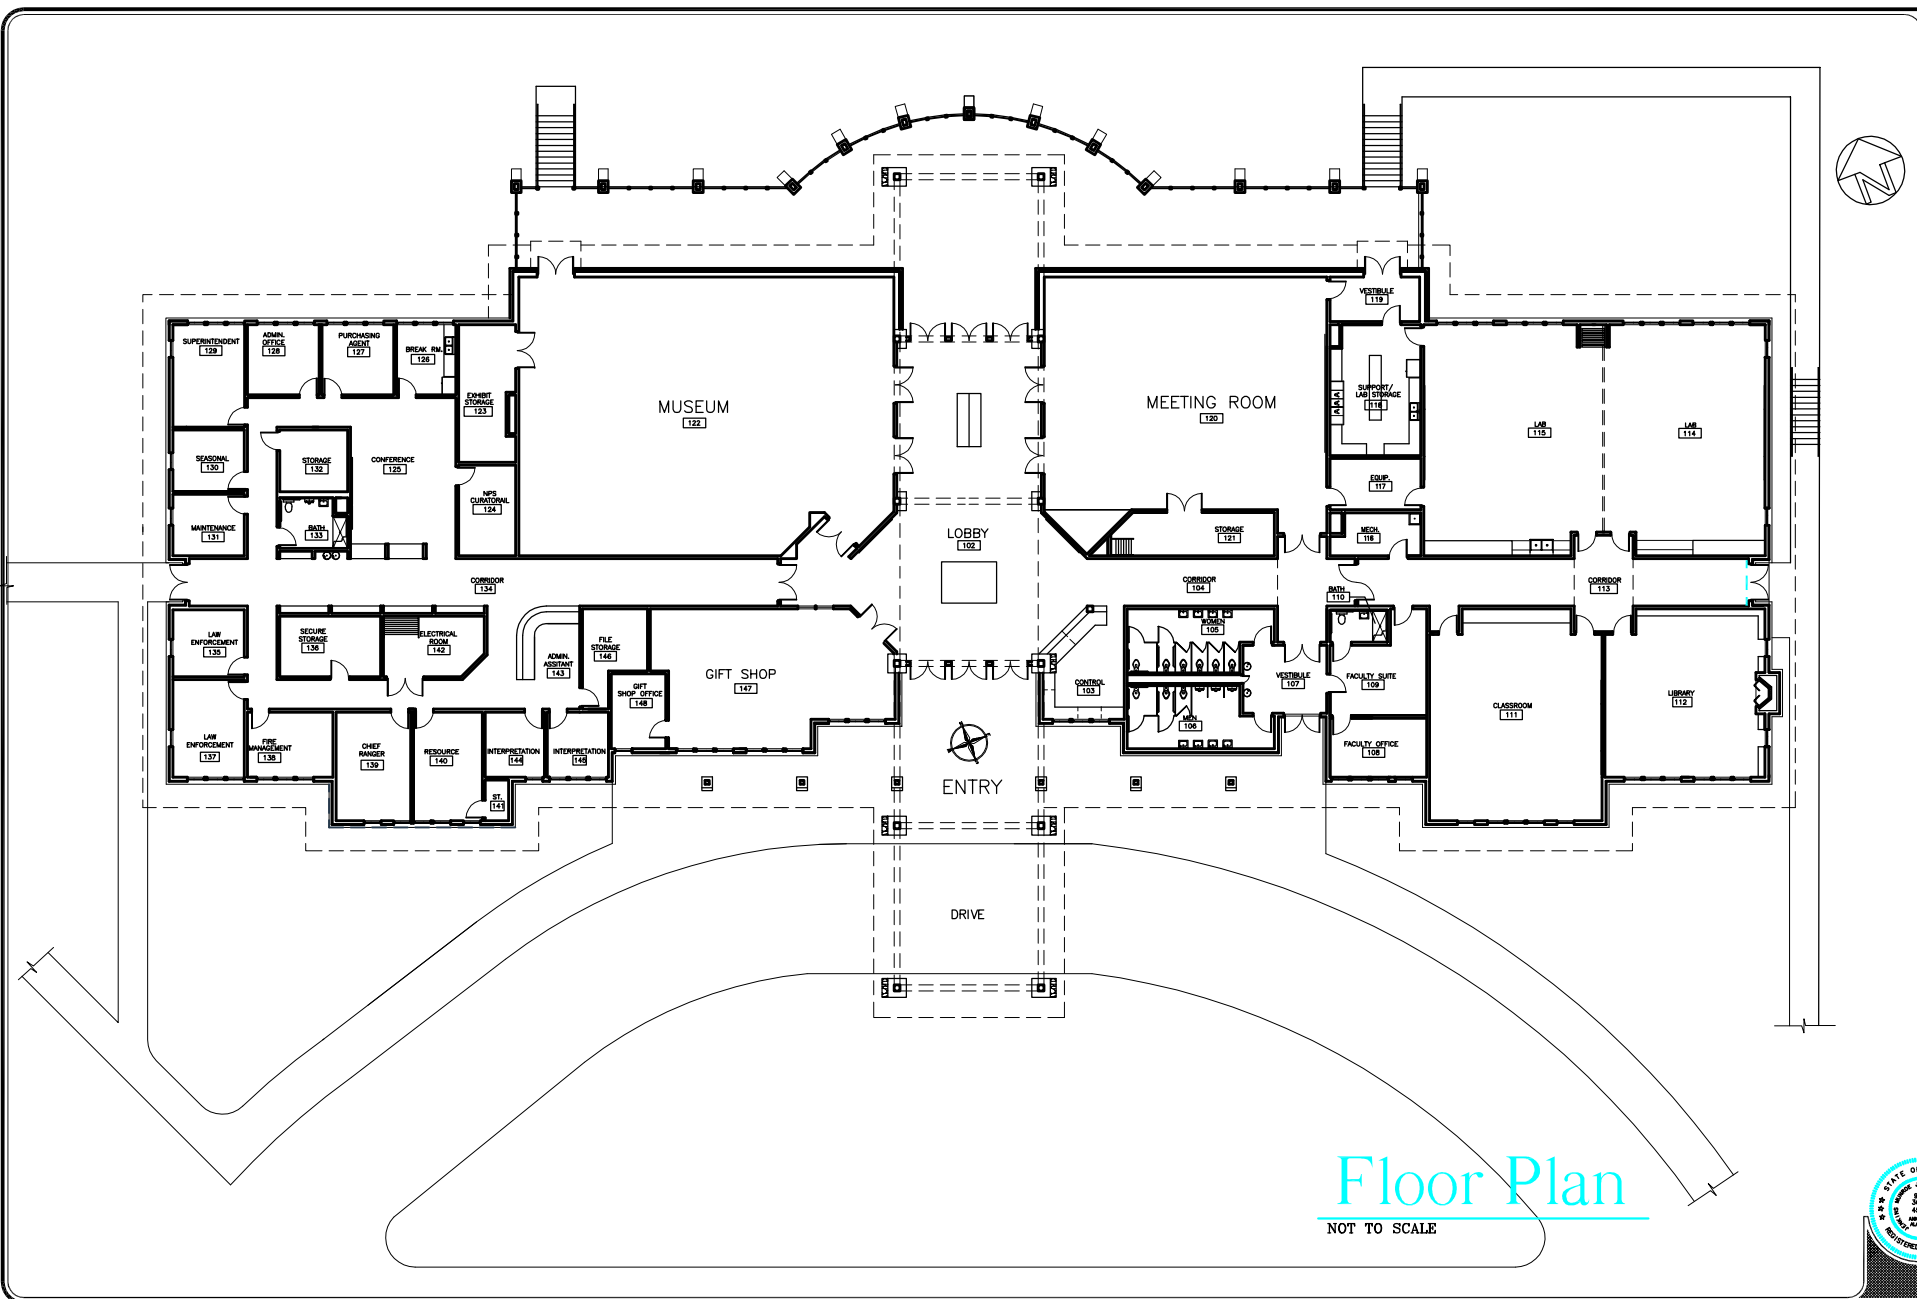

Floor Plan

NOT TO SCALE



Jenkins Mumroe Jenkins architecture
Members of the American Institute of Architects

DATE: 01-15-07
REVISED:
FILE: 03137
DRAWN:

Little River Canyon Center
Jacksonville State University

SHEET:
A1.0

